


VENTILATION REQUIREMENTS:

COMPONENT	QUANTITY	DUCT DIA.	TOTAL CFM
CABINET	1	5"	475
SEPARATOR	1	5"	475
			950

BASE SIZE OF ALL DUCT ON A MINIMUM DUCT VELOCITY OF 3500 LFM. GATHER BOTH VENTS INTO AN 7" DIA. DUCT AND RUN TO DUST COLLECTOR.

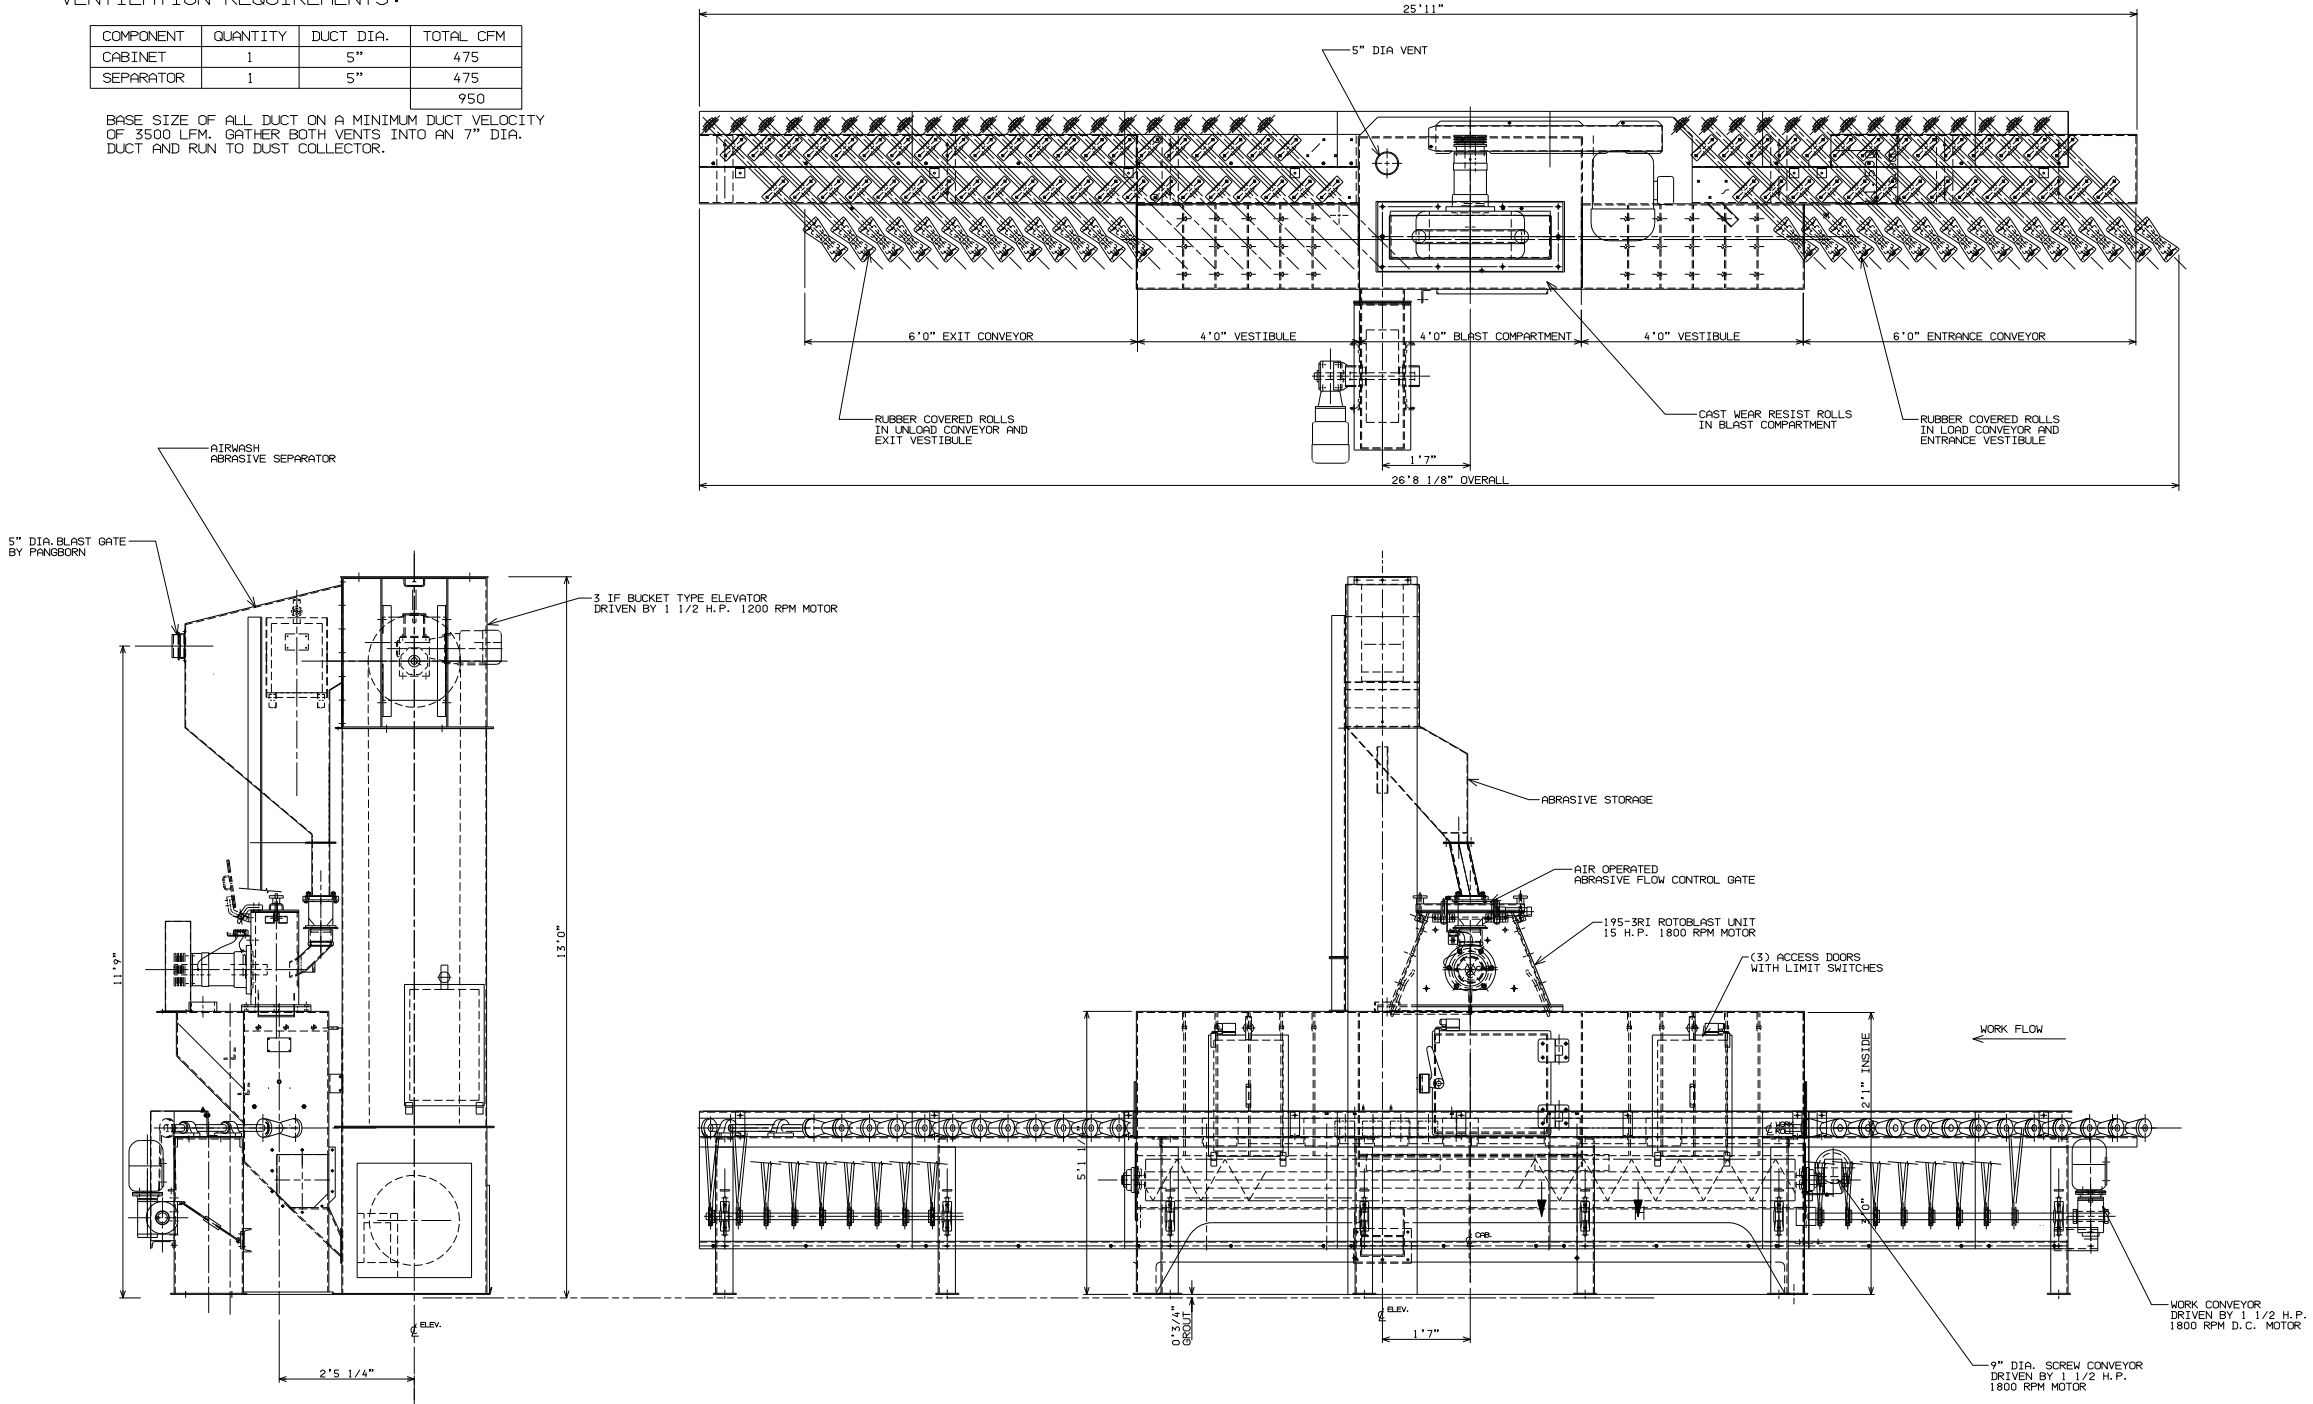

FRONT ELEVATION

FOR FOUNDATION SEE H-980471

LAST REVISION		THIS DRAWING AND THE INFORMATION CONTAINED HEREIN ARE CONFIDENTIAL AND THE PROPERTY OF PANGBORN. NO USE OF OR DISCLOSURE OF THIS DRAWING OR THE INFORMATION CONTAINED THEREIN SHALL BE MADE WITHOUT THE SPECIFIC PRIOR WRITTEN CONSENT OF PANGBORN. AND THIS DRAWING SHALL BE RETURNED THEREUPON AT THE REQUEST OF PANGBORN. POSSESSION OF THIS DRAWING SHALL CONSTITUTE YOUR AGREEMENT TO THE FOREGOING TERMS AND CONDITIONS. COPYRIGHT PANGBORN CO. © 2000	
DRAWN	APPR.	DATE	
DESCRIPTION			
DRAWN DD		TITLE	
CHECKED VS		GENERAL ARRANGEMENT	
APPR. REP		E. V. I. TOOL	
DATE 6/12/98		MACHINE: ES-1920-2	
SCALE 1:8		DWG. NO. L-980571	
UNLESS OTHERWISE SPECIFIED ALL DIMENSIONS ARE IN INCHES		TOLERANCES UNLESS OTHERWISE SPECIFIED ARE PER DWG. S-830150 DO NOT SCALE DRAWING	
S.O.# 301-8149		REV. SHEET 1 OF 1	
PANGBORN			